

Legend

REF	REFRIGERATOR
SSS	STAINLESS ST. SINK
VB	VANITY BASIN
SHR	SHOWER OVER
SKL	SKYLIGHT VENTILATION
WM	WASHING MACHINE
HP	HOT PLATE
PAN	PANTRY
DP	DOWN PIPE OUTLET
FW	FLOOR WASTE GULLY
T	TUB
HWU	HOT WATER UNIT
ST	STORAGE CUP'D

Window Schedule


CODE	D	x	W
SP-W3A	1200	x	860
W3B	1200	x	820
SP-W8A	1200	x	1860
W8A	1200	x	1860
OBS	OBSCURED		
XO	UNLESS NOTED OTHERWISE		

FLOOR AREA PER UNIT

INT. HABITABLE AREA	= 94.50 m ²
CARPORT	= 19.25 m ²
BALCONY & PORCH	= 33.00 m ²
TOTAL EACH UNIT	= 146.75 m²

Door Schedule

NO.	DESCRIPTION	METRIC SIZE (DxW)	NOTES
001	EXT. WOOD MADISON PWD104 w/ PWD104 SIDE LITE	2040 x 820 (OPENS IN)	ENTRY, LH
002	EXT. WOOD MADISON PWD104 w/ PWD104 SIDE LITE	2040 x 820 (OPENS IN)	ENTRY, RH
003	ALUM. FRAMED SLIDING GLASS DOOR w/ FLYSCREEN	2100 x 1810	OX
004	ALUM. FRAMED SLIDING GLASS DOOR w/ FLYSCREEN	2100 x 1810	XO
005	INTERNAL WOOD 'COL'	2040 x 820	
006	INTERNAL WOOD 'COL'	2040 x 770	
007	INT. SLIDING ROBE 'COL' (3 LEAF)	FRAME 2097x2282	
008	INT. SLIDING ROBE 'COL' (2 LEAF)	FRAME 2097x1343	
009	INT. WOOD 'COL', DOUBLE (C:PBD)	2040 x 2/620	

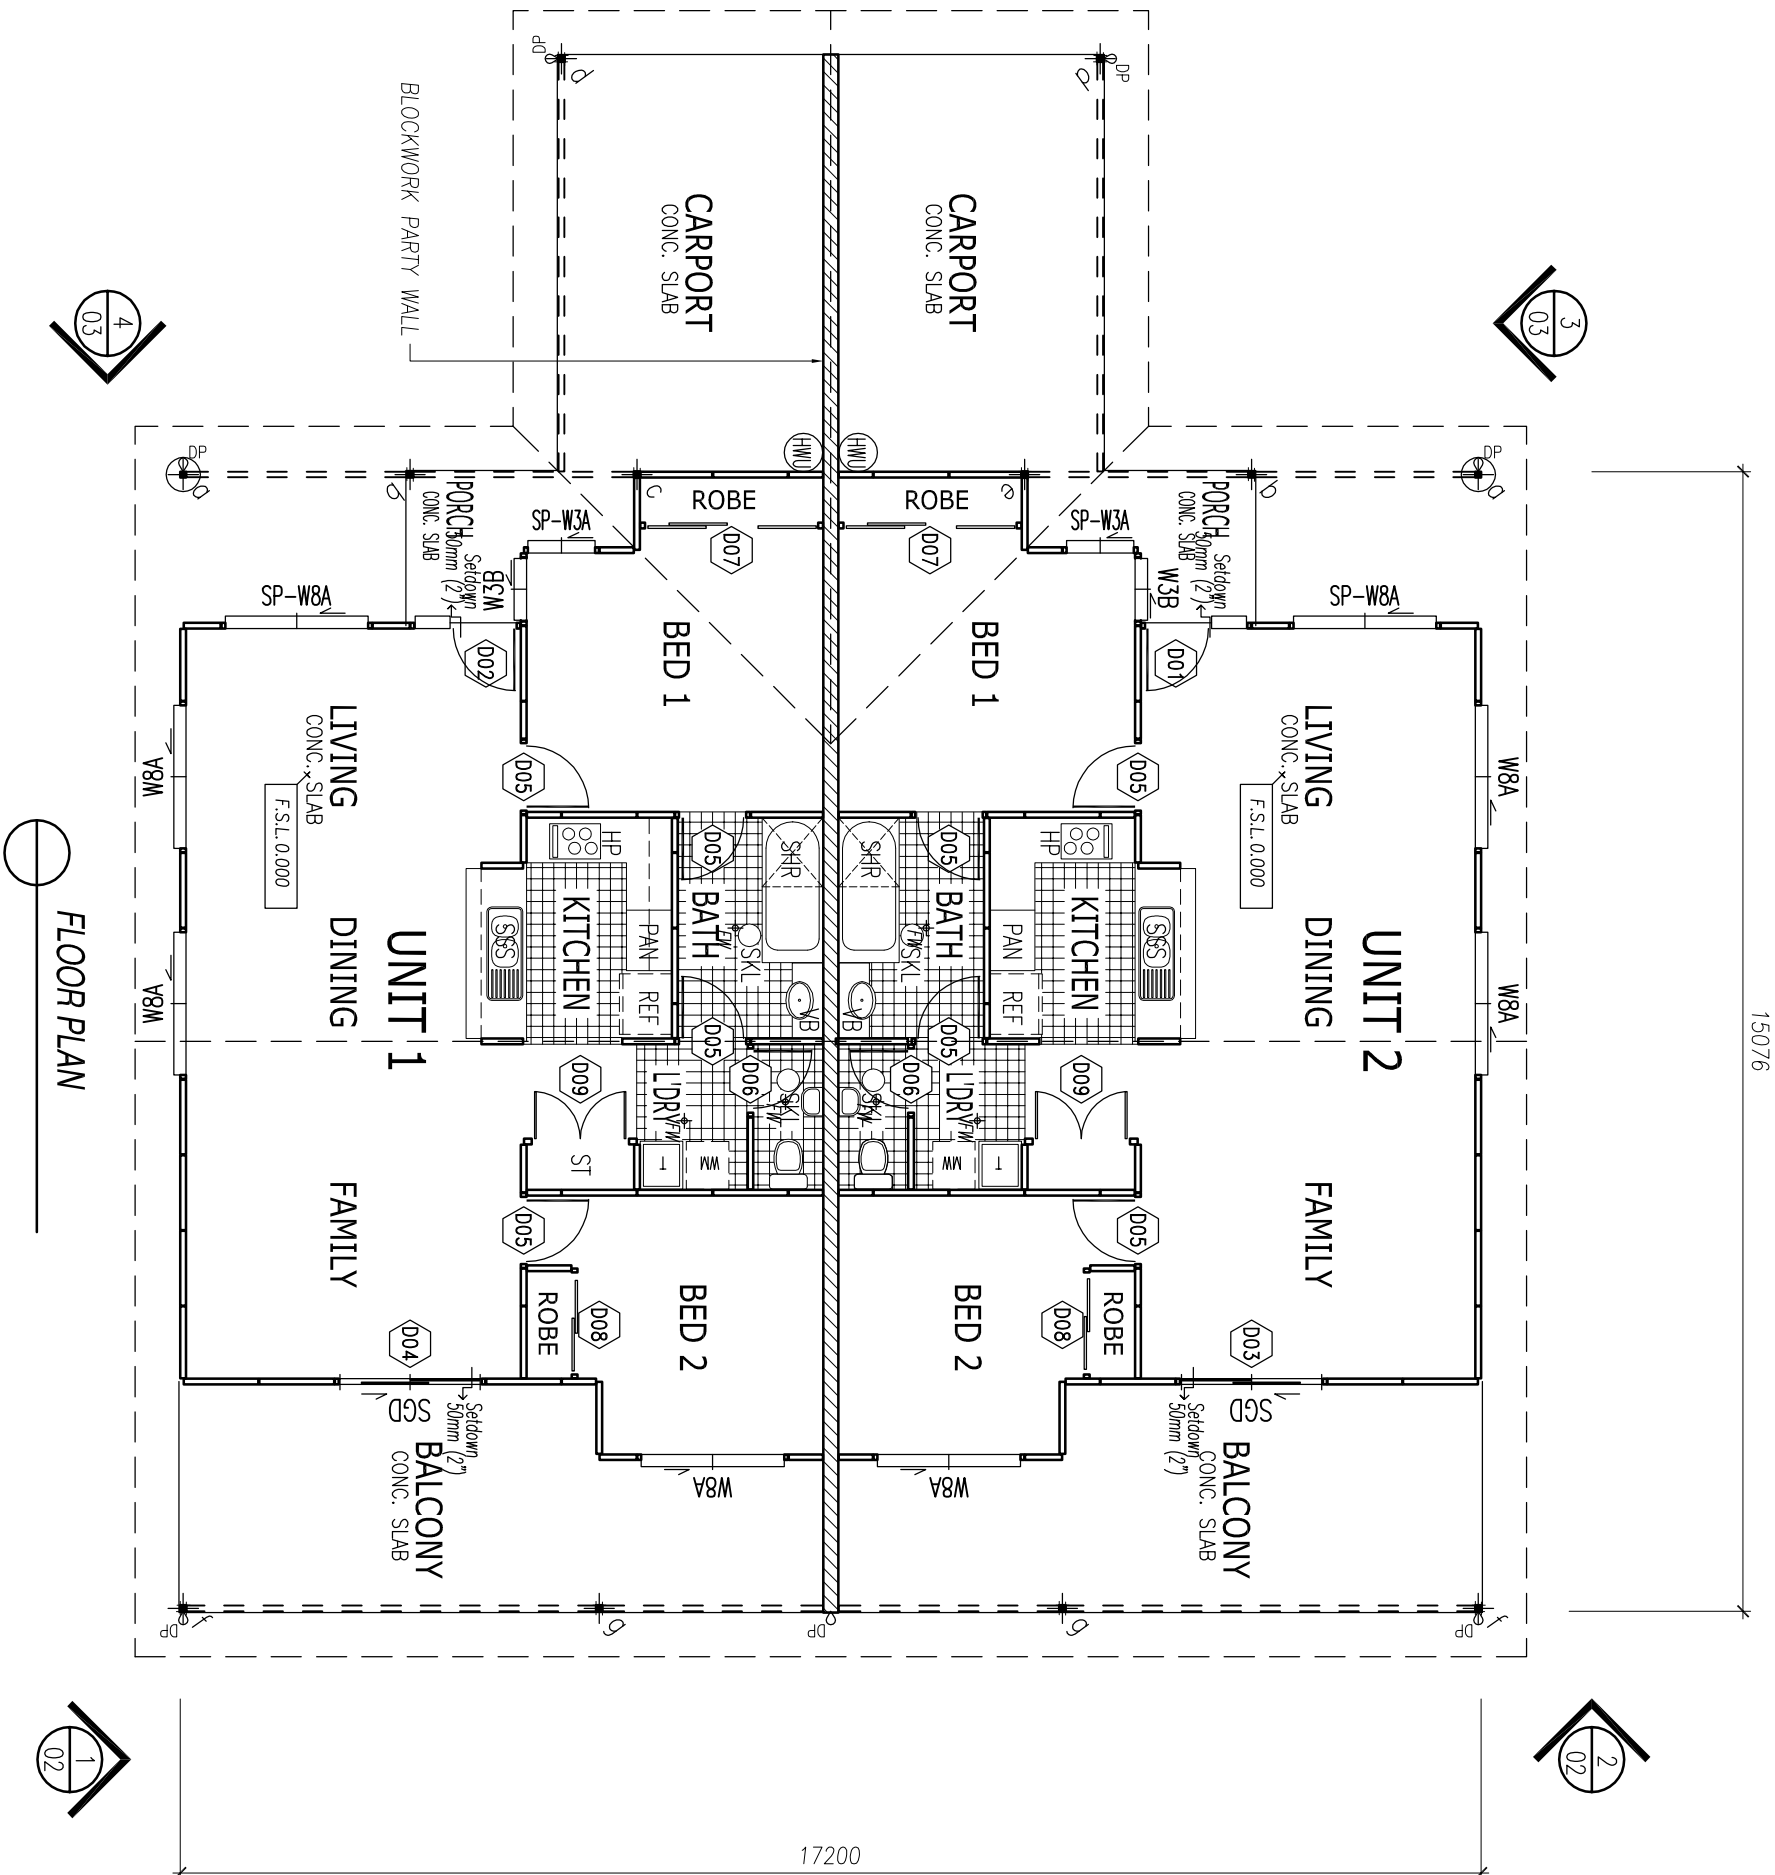

FORCE10
 "BUILDING SOLUTIONS FOR THE WORLD"
 QUALITY APPROVED TO AS/NZS ISO9001

FORCE 10 INTERNATIONAL PTY LTD
 63 FACTORY ROAD, OXLEY
 QUEENSLAND, AUSTRALIA 4075
 PH. +61 7 33795200 FX. +61 7 33795211
 email: info@force10.com.au

CONTENTS

PG	CONTENTS	PG
01	FLOOR PLAN	11
02	ELEVATIONS 1 & 2	
03	ELEVATIONS 3 & 4	
04	PANEL LAYOUT	
05	BRACING PLAN	
06	SLAB DIMENSIONS	
07	TRUSS LAYOUT	
08	SLAB / BOLT PLAN	
09	PURLIN SETOUT	
10	ELECTRICAL LAYOUT	

REV


REV	BY	DATE
-	-	-
-	-	-

DRAWN BY : TTD
DATE : 04/11/08
CHECKED :
SCALE : 1:100 @ A3
DRAWING # : DUPLEX-01


PROJECT : DUPLEX
2 BED DUPLEX

TENDER # : -
JOB# : DUPLEX

-

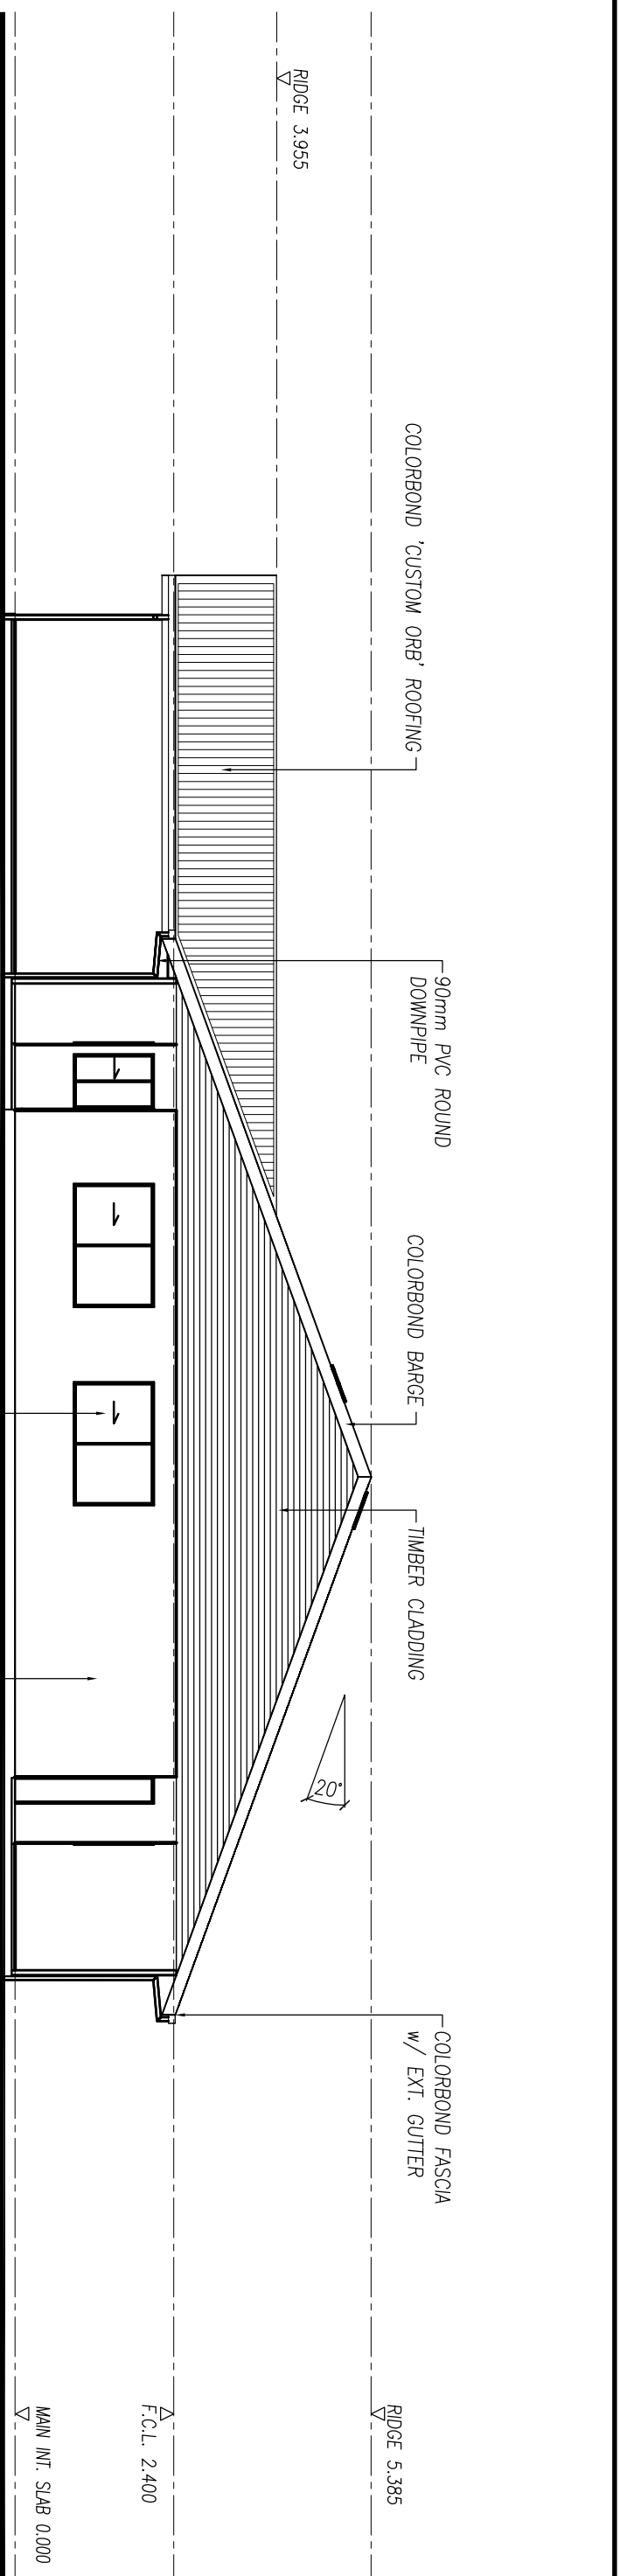

1
01 ELEVATION

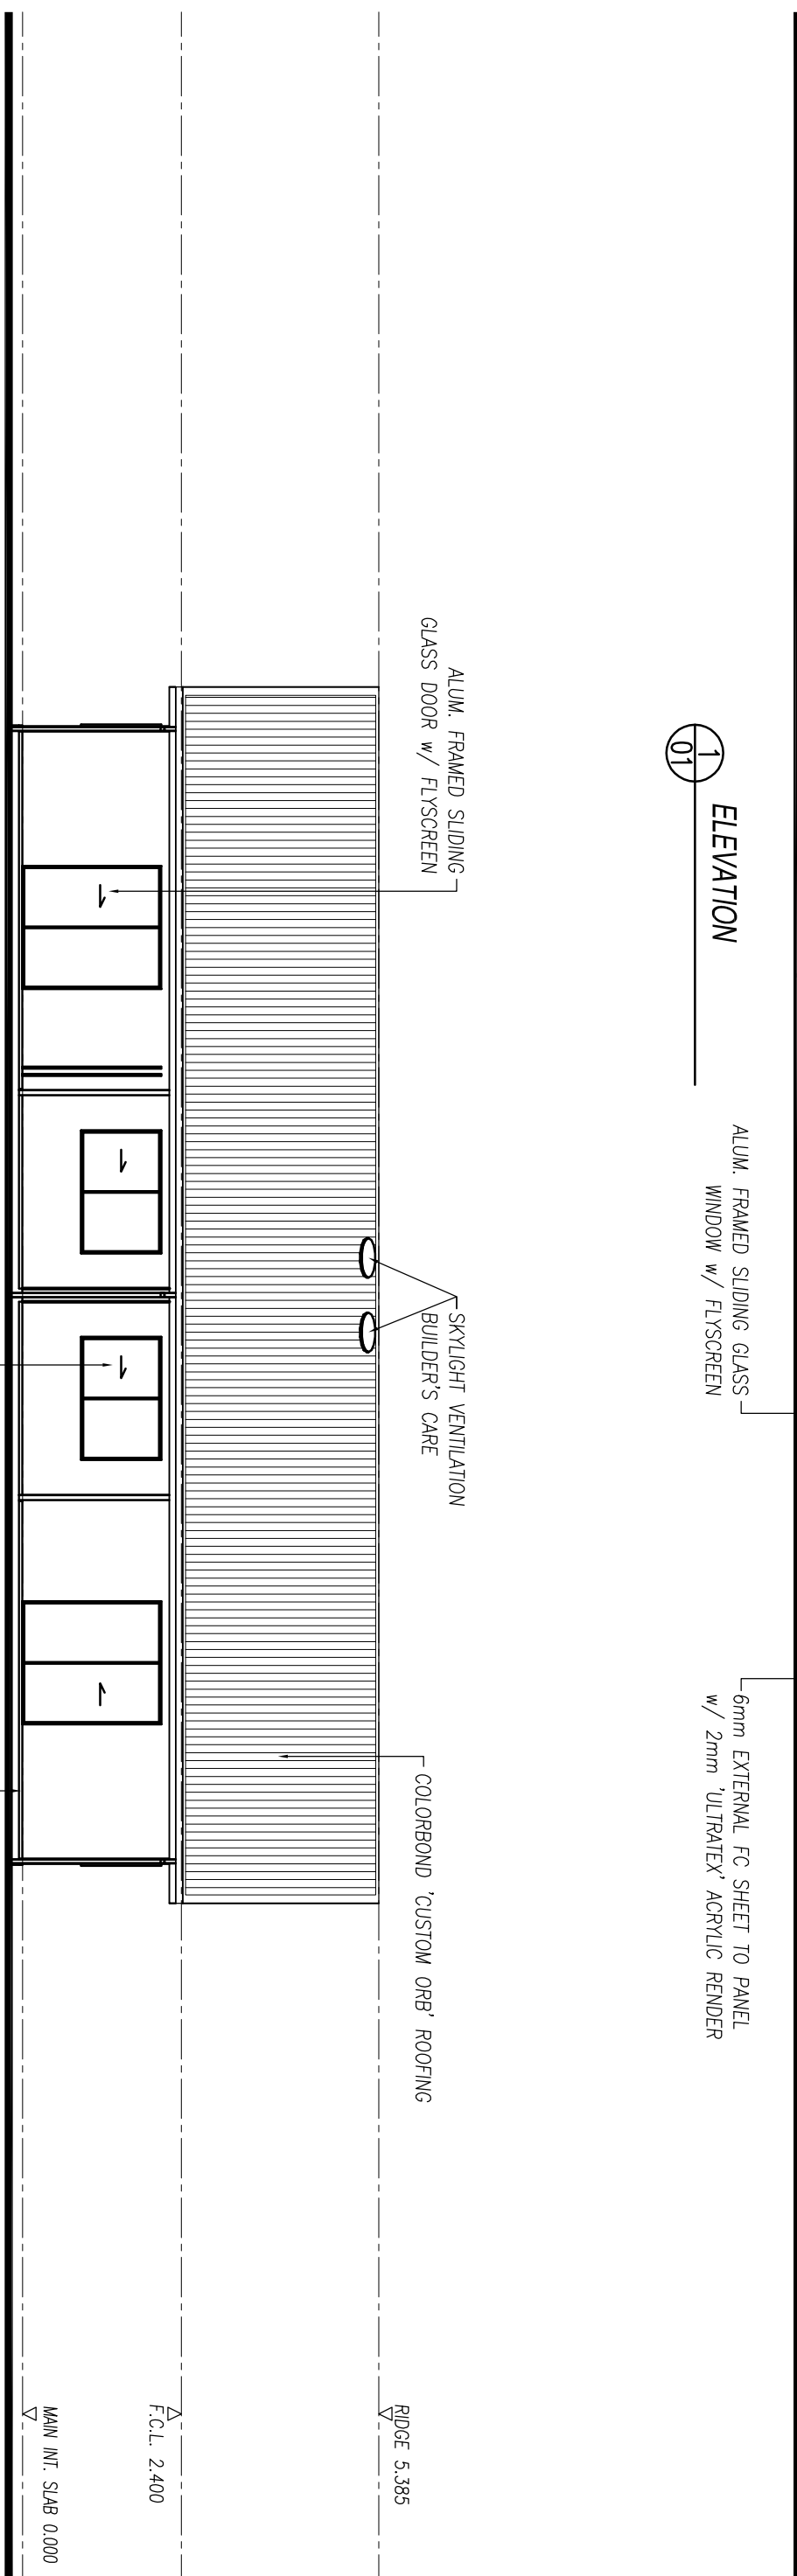

2
01 ELEVATION

ALUM. FRAMED SLIDING GLASS WINDOW w/ FLYSCREEN

CONC. SLAB & FOOTING TO ENGINEER'S DESIGN & SPEC.

FORCE10TM


"BUILDING SOLUTIONS FOR THE WORLD"
QUALITY APPROVED TO AS/NZS ISO9001

FORCE 10 INTERNATIONAL PTY LTD
63 FACTORY ROAD, OXLEY
QUEENSLAND, AUSTRALIA 4075
PH. +61 7 33795200 FX. +61 7 33795211
emaii:-- info@force10.com.au

THE FORCE 10 ENGINEERED BUILDING SYSTEM IS PROTECTED BY WORLD-WIDE PATENTS. THIS DRAWING MAY NOT BE COPIED OR REPRODUCED IN PART OR WHOLE WITHOUT WRITTEN CONSENT FROM FORCE 10.

CONTENTS	PG	CONTENTS	PG
FLOOR PLAN	01	PERSPECTIVES	11
ELEVATIONS 1 & 2	02		
ELEVATIONS 3 & 4	03		
PANEL LAYOUT	04		
BRACING PLAN	05		
SLAB DIMENSIONS	06		
SLAB / BOLT PLAN	07		
TRUSS LAYOUT	08		
PURLIN SETOUT	09		
ELECTRICAL LAYOUT	10		


DRAWN BY : TD	PROJECT : DUPLEX
DATE : 04/11/08	2 BED DUPLEX
CHECKED :	TENDER # : -
SCALE : 1:100	JOB# : DUPLEX
DRAWING # : DUPLEX-02	

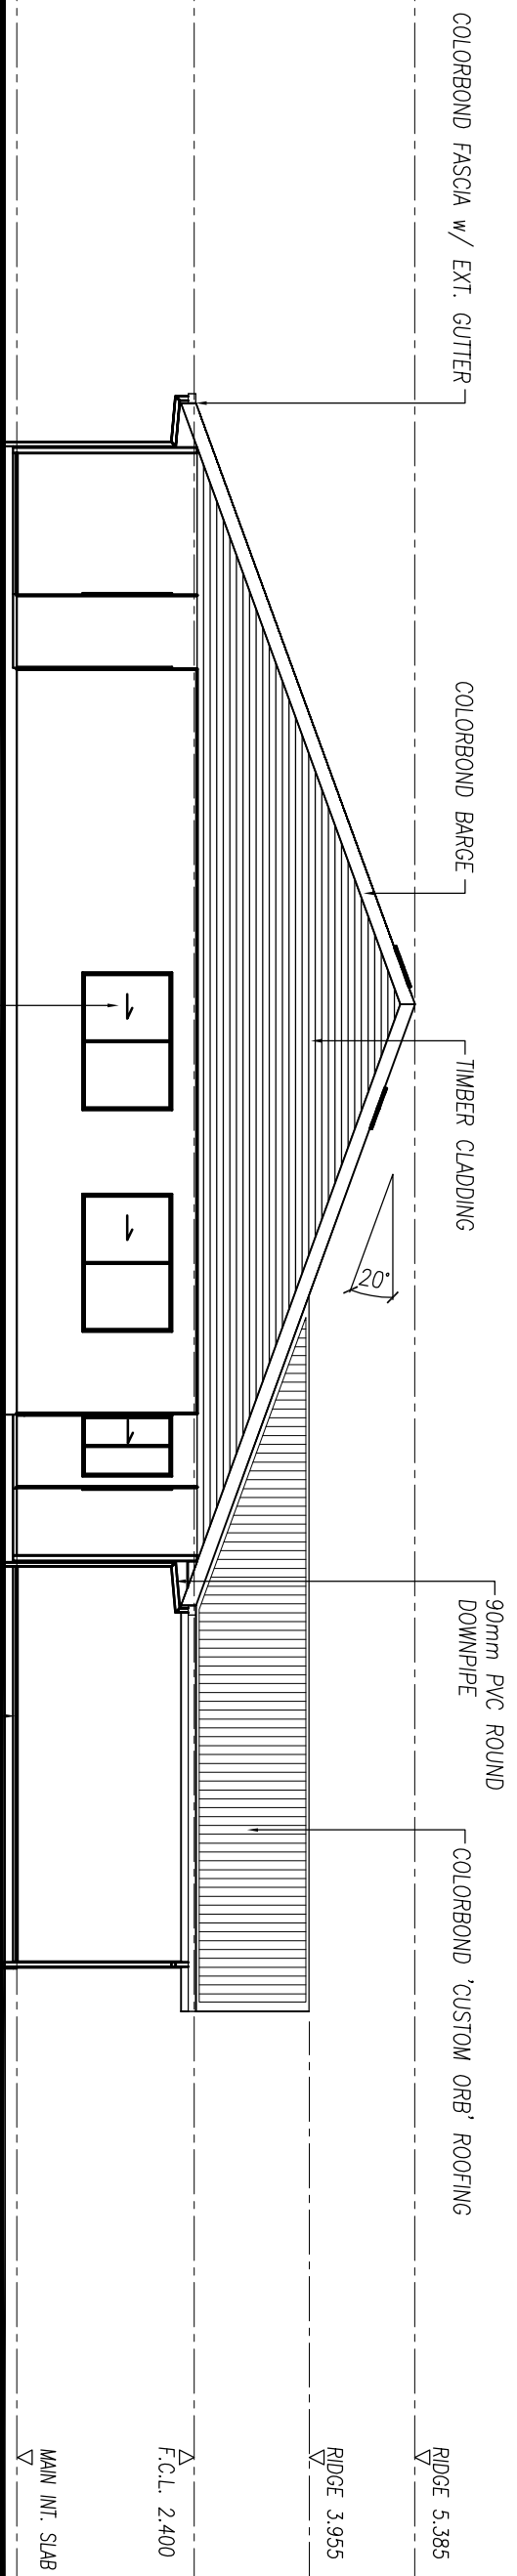

3
01
ELEVATION

ALUM. FRAMED SLIDING GLASS WINDOW w/ FLYSCREEN

CONC. SLAB & FOOTING TO ENGINEER'S DESIGN & SPEC.

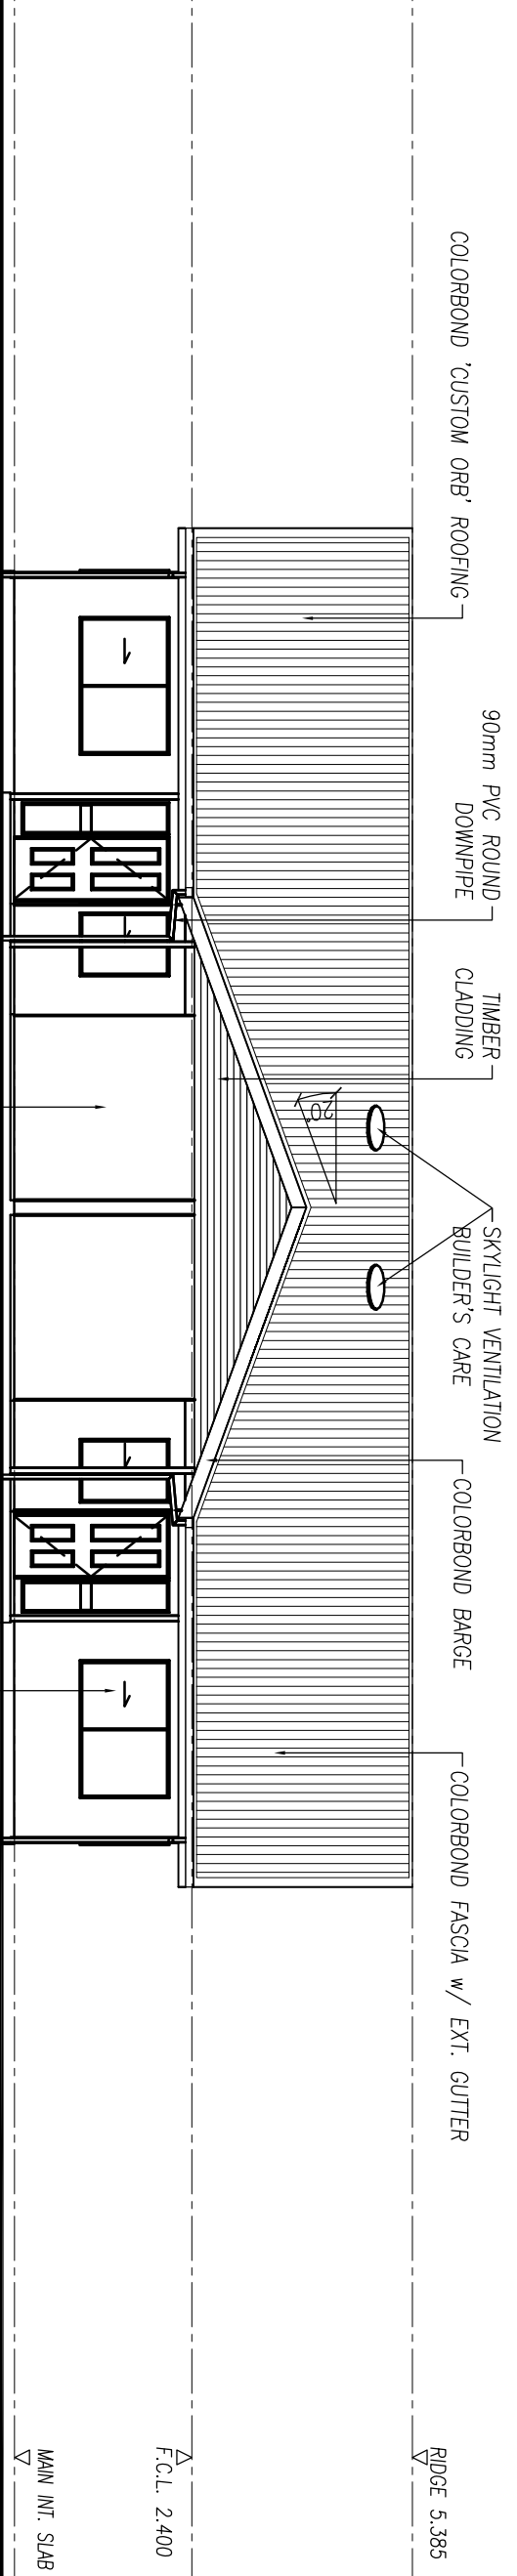

4
01
ELEVATION

6mm EXTERNAL FC SHEET TO PANEL w/ 2mm 'ULTRATEX' ACRYLIC RENDER


ALUM. FRAMED SLIDING GLASS WINDOW w/ FLYSCREEN

FORCE10TM
 "BUILDING SOLUTIONS FOR THE WORLD"
 QUALITY APPROVED TO AS/NZS ISO9001


FORCE 10 INTERNATIONAL PTY LTD
 63 FACTORY ROAD, OXLEY
 QUEENSLAND, AUSTRALIA 4075
 PH. +61 7 33795200 FX. +61 7 33795211
 email:- info@force10.com.au
 THE FORCE 10 ENGINEERED BUILDING SYSTEM IS PROTECTED BY WORLD-WIDE PATENTS. THIS DRAWING MAY NOT BE COPIED OR REPRODUCED IN PART OR WHOLE WITHOUT WRITTEN CONSENT FROM FORCE 10.

CONTENTS	PG	CONTENTS	PG
FLOOR PLAN	01	PERSPECTIVES	11
ELEVATIONS 1 & 2	02		
ELEVATIONS 3 & 4	03		
PANEL LAYOUT	04		
BRACING PLAN	05		
SLAB DIMENSIONS	06		
SLAB / BOLT PLAN	07		
TRUSS LAYOUT	08		
PURLIN SETOUT	09		
ELECTRICAL LAYOUT	10		

DRAWN BY : TD	PROJECT	DUPLEX
DATE : 04/11/08		2 BED DUPLEX
CHECKED :	TENDER # :	-
SCALE : 1:100	JOB# :	DUPLEX
	DRAWING # :	DUPLEX-03

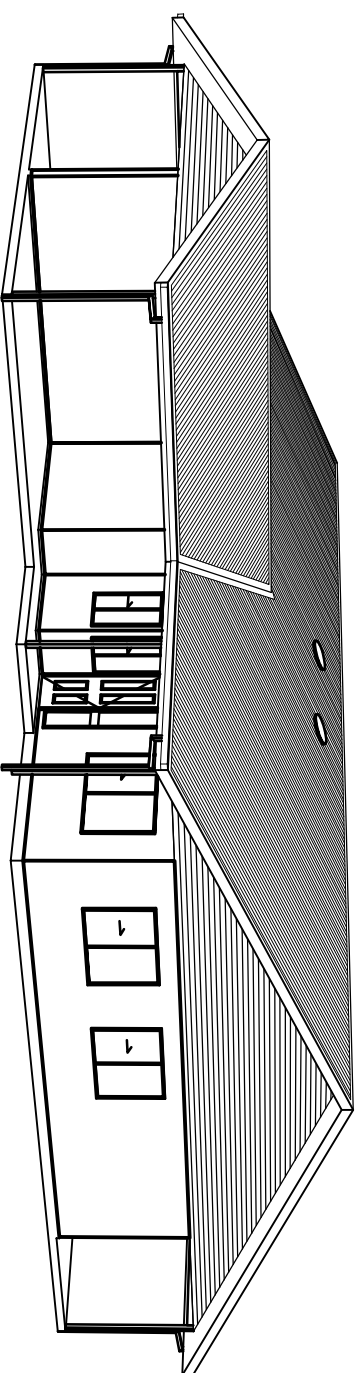

○ PERSPECTIVE 1

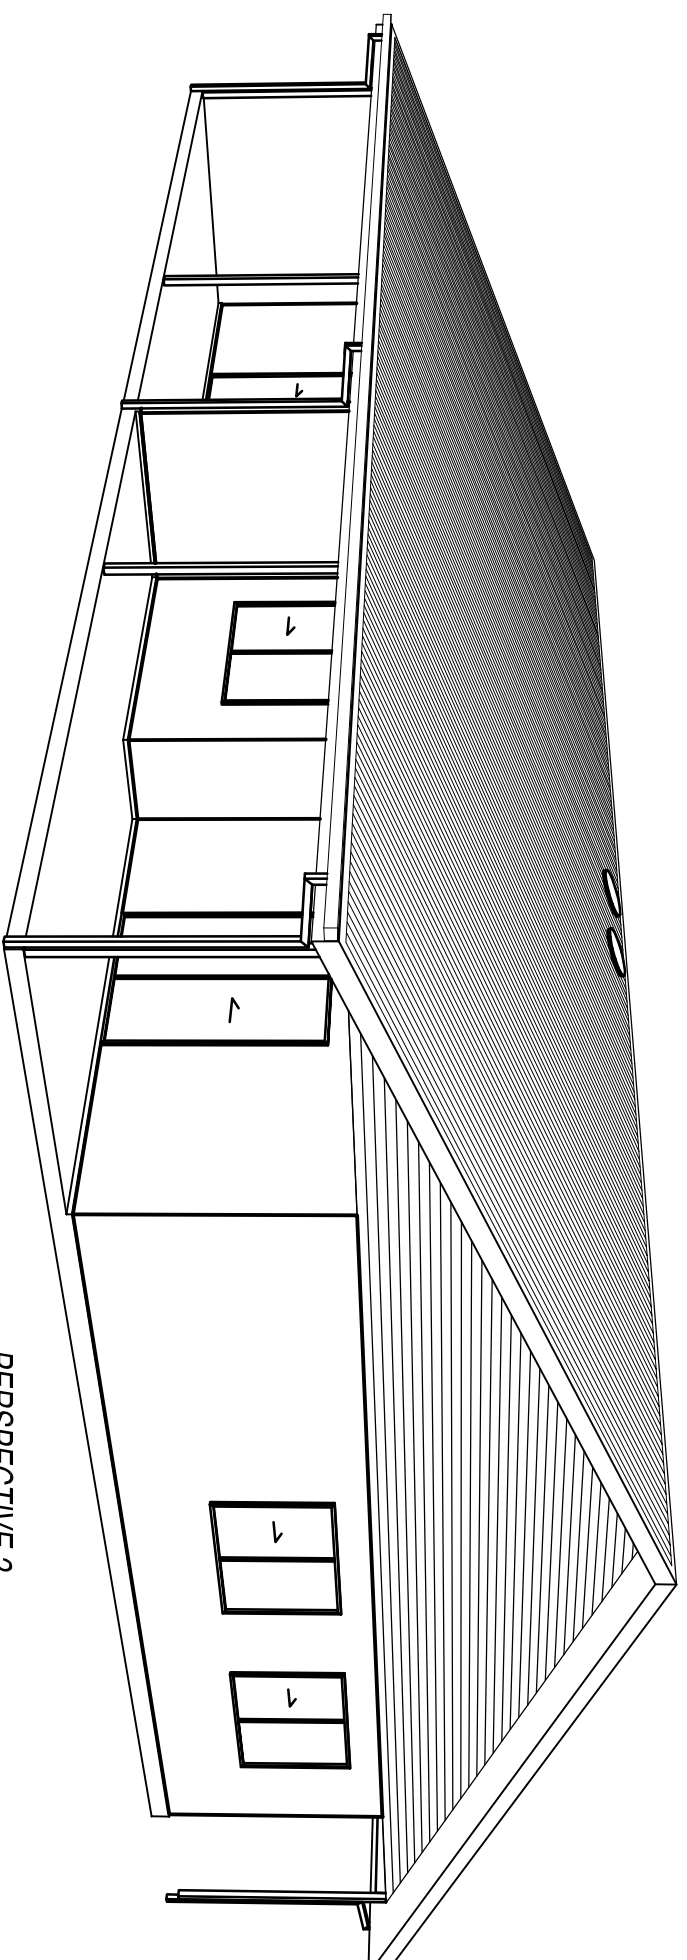

○ PERSPECTIVE 2

FORCE 10 INTERNATIONAL PTY LTD
 63 FACTORY ROAD, OXLEY
 QUEENSLAND, AUSTRALIA 4075
 PH. +61 7 33795200 FX. +61 7 33795211
 email:— info@force10.com.au

THE FORCE 10 ENGINEERED BUILDING SYSTEM IS PROTECTED BY PATENT RIGHTS. THIS DRAWING MAY NOT BE COPIED OR REPRODUCED IN PART OR WHOLE WITHOUT WRITTEN CONSENT FROM FORCE 10 INTL. PTY LTD.

CONTENTS	PG	CONTENTS	PG
FLOOR PLAN	01	PERSPECTIVES	11
ELEVATIONS 1 & 2	02		
ELEVATIONS 3 & 4	03		
PANEL LAYOUT	04		
BRACING PLAN	05		
SLAB DIMENSIONS	06		
SLAB / BOLT PLAN	07		
TRUSS LAYOUT	08		
PURLIN LAYOUT	09		
ELECTRICAL LAYOUT	10		

DRAWN BY : TD	PROJECT : DUPLEX
DATE : 04/11/08	2 BED DUPLEX
CHECKED :	TENDER # : -
SCALE : n.t.s. @ A3	JOB# : DUPLEX
DRAWING # : DUPLEX-11	-

REV	BY	DATE	DRAWING REVISIONS
-	-	-	

FORCE10TM
 "BUILDING SOLUTIONS FOR THE WORLD"
 QUALITY APPROVED TO AS/NZS ISO9001