


Window Schedule

CODE	H	x	W
W2A	900	x	860
W3A	1200	x	860
W7A	900	x	1860
W8A	1200	x	1860
W8B	1200	x	1820

OBS OBSCURED
XO UNLESS NOTED OTHERWISE

Door Schedule

NO.	DESCRIPTION	METRIC SIZE (DxW)	NOTES
001	EXT. WOOD CLASSIC PCL9 (STD)	2040 x 820	ENTRY
002	GLASS DESIGNS No.2	2040 x 820	
003	ALUM. FRAMED SLIDING GLASS DOOR w/ FLYSCREEN	2100 x 1810	XO
004	INTERNAL WOOD, 'STANFORD' STA	2040 x 770	
005	INTERNAL WOOD, 'STANFORD' STA	2040 x 820	
006	INT. SLIDING ROBE 'STANFORD' (2 LEAF)	2040 x 2/620	209/1343 RR
007	INT. SLIDING ROBE 'STANFORD' (2 LEAF)	2040 x 2/820	209/1743 RR

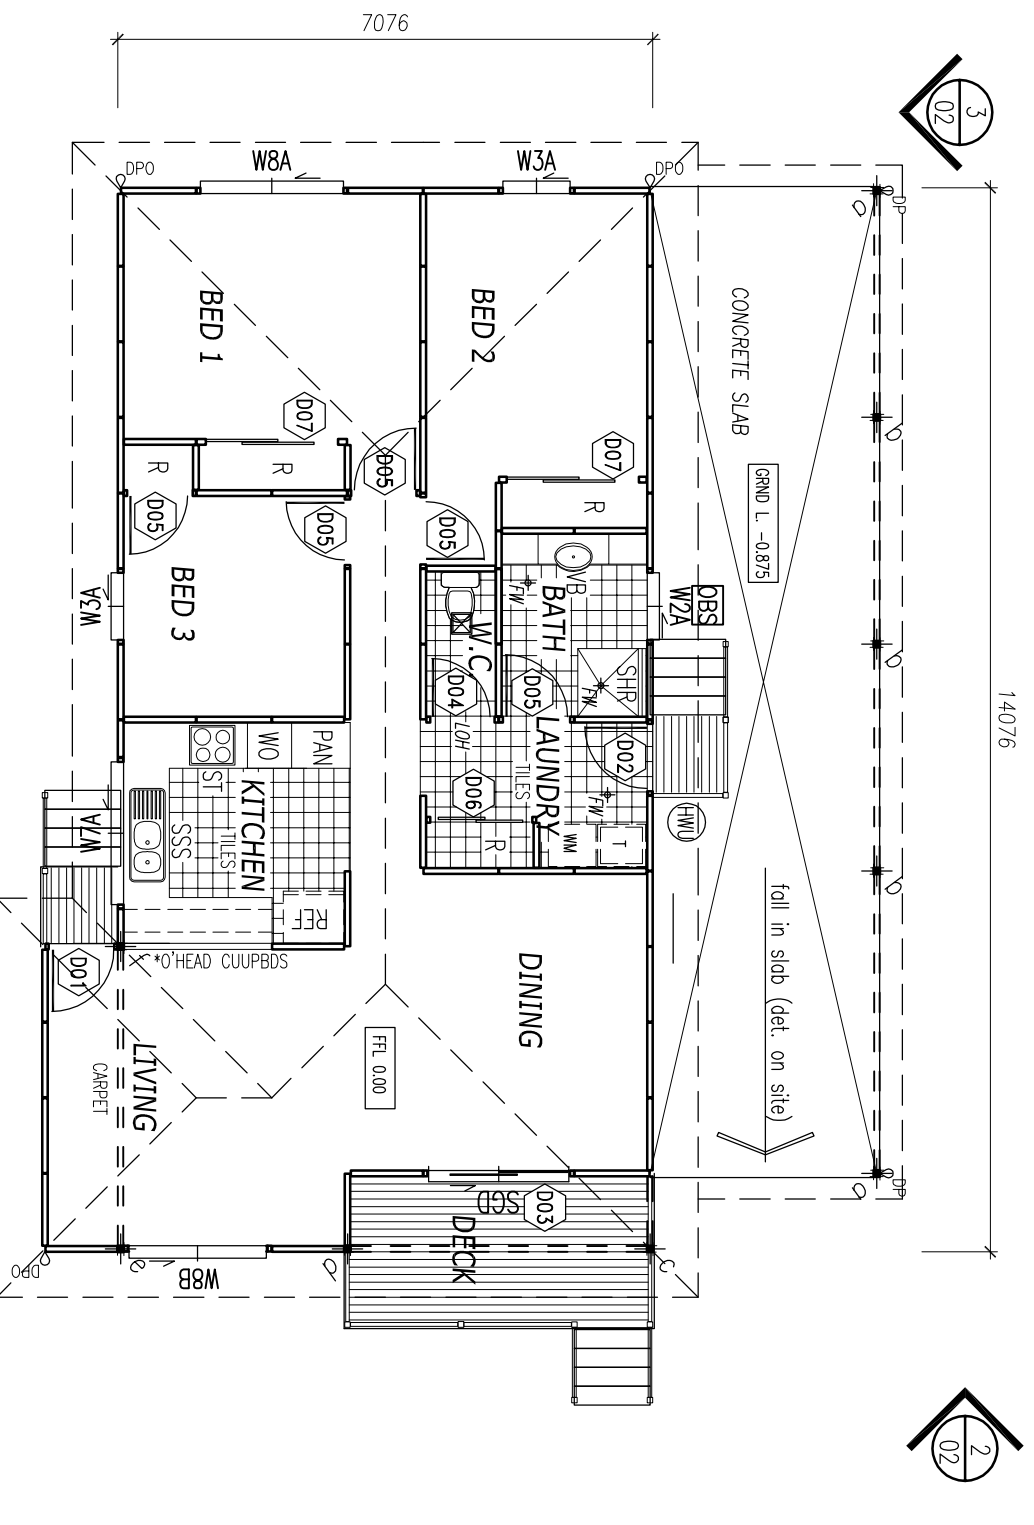

Legend

REF	REFRIGERATOR
SSS	STAINLESS ST. SINK (1 1/2 BOWL)
VB	VANITY BASIN
SHR	SHOWER PAN
T	TUB - LAUNDRY
WM	WASHING MACHINE
LOH	LEFT-OFF HINGE
PAN	PANTRY
WO	WALL OVEN
R	ROBE
DP	DOWN PIPE OUTLET
FW	FLOOR WASTE GULLY
HWL	VENTED SKY LIGHT
HWU	HOT WATER UNIT

FLOOR AREAS

ENCLOSED HABITABLE AREA	=	98.00 m ²
CARPOR	=	39.00 m ²
DECK & LANDING'S	=	10.00 m ²
TOTAL	=	147.00 m ²

FLOOR PLAN

FORCE10
 "BUILDING SOLUTIONS FOR THE WORLD"
 QUALITY APPROVED TO AS/NZS ISO9001

FORCE 10 INTERNATIONAL PTY LTD
 63 FACTORY ROAD, OXLEY
 QUEENSLAND, AUSTRALIA 4075
 PH. +61 7 33795200 FX. +61 7 33795211
 email: - info@force10.com.au
 web: - http://www.force10.com.au


CONTENTS	PG	CONTENTS	PG
SITE PLAN	00		
FLOOR PLAN	01		
ELEVATIONS	02		
PAN & BRA	03		
BEARER & STUMPS	04		
ROOF & PURLIN	05		
ELECTRICAL LAYOUT	06		
PERSPECTIVE	07		

DRAWN BY : KS
 DATE : 15/02/2009
 CHECKED :
 SCALE : 1:100 @ A3

PROJECT RIVER
 3 BEDROOM WITH CARPORT
 TENDER # : T-
 DRAWING # : RIVER-01
 JOB# : RIVER


REV	BY	DATE
-	-	-

DRAWING REVISIONS

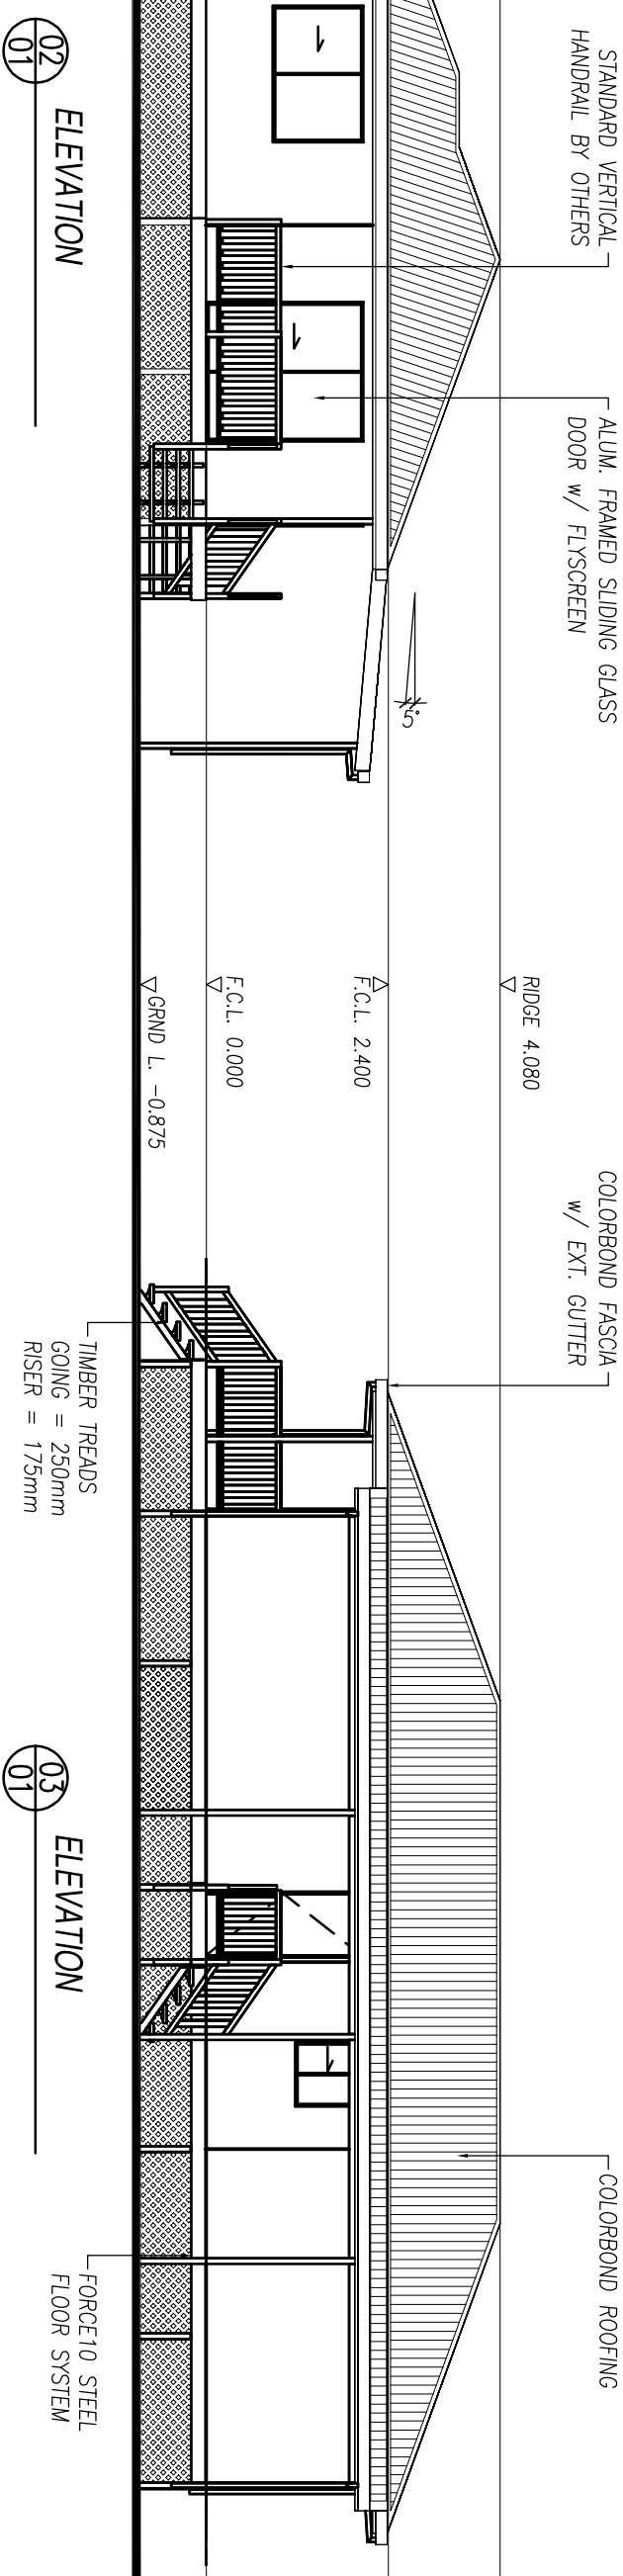

02
01 ELEVATION

03
01 ELEVATION

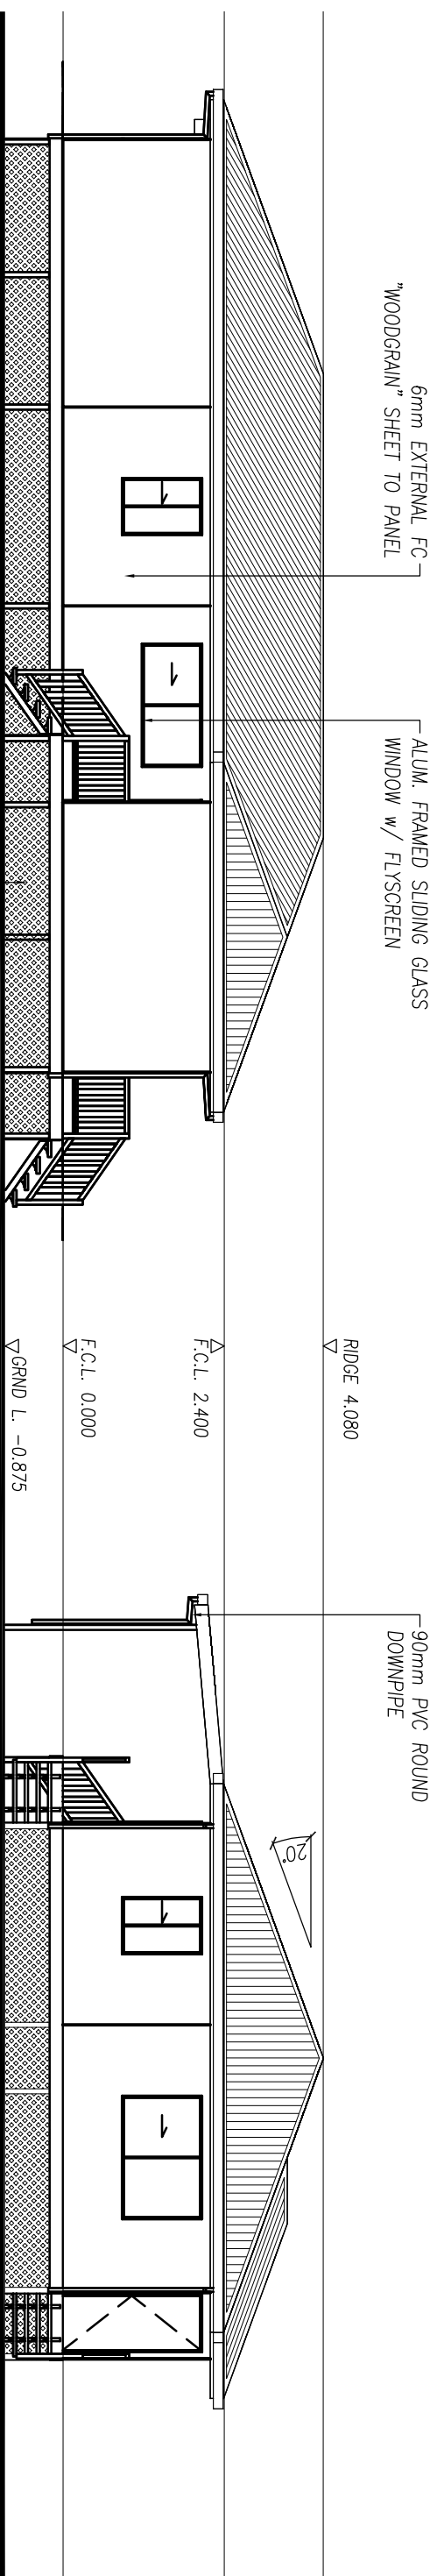

01
01 ELEVATION

04
01 ELEVATION

FORCE10
 "BUILDING SOLUTIONS FOR THE WORLD"
 QUALITY APPROVED TO AS/NZS ISO9001


FORCE 10 INTERNATIONAL PTY LTD
 63 FACTORY ROAD, OXLEY
 QUEENSLAND, AUSTRALIA 4075
 PH. +61 7 33795200 FX. +61 7 33795211
 email: - info@force10.com.au
 web: - http://www.force10.com.au

CONTENTS	PG	CONTENTS	PG
SITE PLAN	00		
FLOOR PLAN	01		
ELEVATIONS	02		
PAN & BRA	03		
BEARER & STUMPS	04		
ROOF & PURLIN	05		
ELECTRICAL LAYOUT	06		
PERSPECTIVE	07		


REV	BY	DATE	DRAWING REVISIONS
-	-	-	-

DRAWN BY : KS
 DATE : 15/02/2009
 CHECKED :
 SCALE : 1:100

PROJECT RIVER
 3 BEDROOM WITH CARPORT
 TENDER # : T-
 DRAWING # : RIVER-02
 JOB# : RIVER

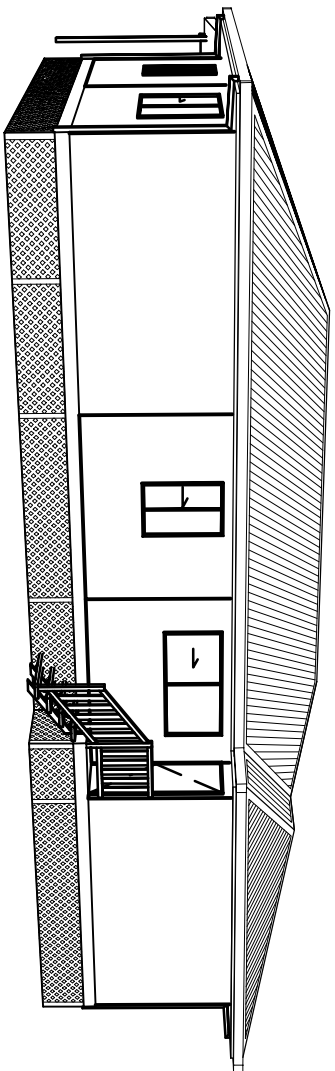

REAR PERSPECTIVE

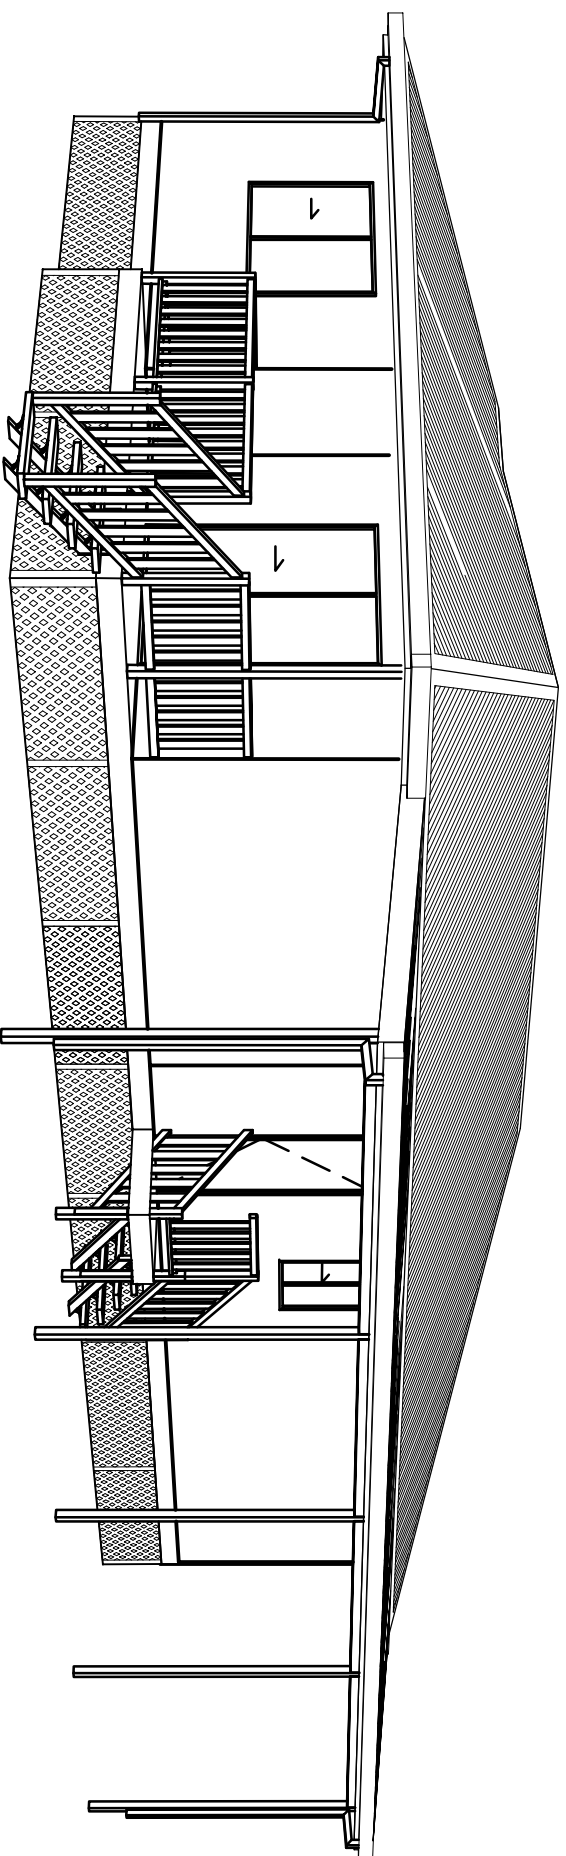

PERSPECTIVE

FORCE 10 INTERNATIONAL PTY LTD

63 FACTORY ROAD, OXLEY
QUEENSLAND, AUSTRALIA 4075
PH. +61 7 33795200 FX. +61 7 33795211
email: - info@force10.com.au
web: - http://www.force10.com.au

THE FORCE 10 ENGINEERED BUILDING SYSTEM IS PROTECTED BY WORLD-
WIDE PATENTS. THIS DRAWING MAY NOT BE COPIED OR REPRODUCED
IN PART OR WHOLE WITHOUT WRITTEN CONSENT FROM FORCE 10.

CONTENTS

SITE PLAN	00
FLOOR PLAN	01
ELEVATIONS	02
PAN & BRA	03
BEARER & STUMPS	04
ROOF & PURLIN	05
ELECTRICAL LAYOUT	06
PERSPECTIVE	07

PG CONTENTS

PG

REV	BY	DATE
-	-	-
-	-	-
-	-	-

DRAWING REVISIONS

DRAWN BY : KS

DATE : 15/02/2009

CHECKED :

SCALE : n.t.s. @ A3

PROJECT

RIVER
3 BEDROOM WITH CARPORT

TENDER # : T-

JOB# : RIVER

DRAWING # : RIVER-07

-

FORCE10TM

"BUILDING SOLUTIONS FOR THE WORLD"
QUALITY APPROVED TO AS/NZS ISO9001